
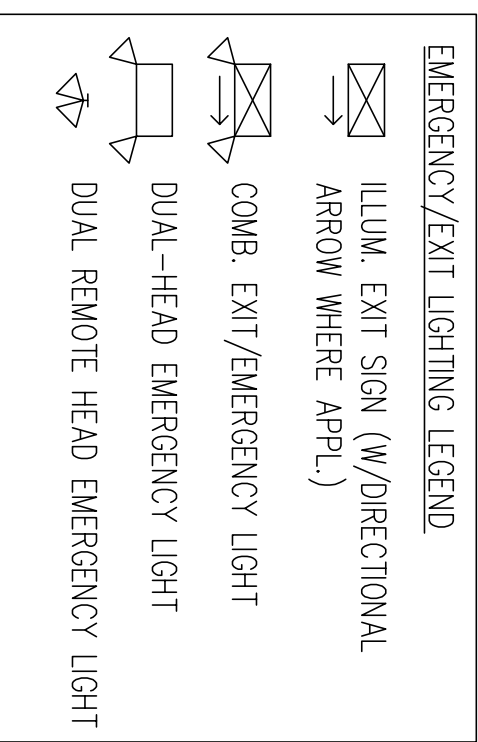


ROOM FINISH SCHEDULE																									
NO.	ROOM NAME	FLOOR			BASE			NORTH WALL			EAST WALL			SOUTH WALL			WEST WALL			CEILING			NO.	SQUARES	
		MAT.	FIN.	MAT.	MAT.	FIN.	MAT.	FIN.	MAT.	FIN.	MAT.	FIN.	MAT.	FIN.	MAT.	FIN.	MAT.	FIN.	MAT.	FIN.	FIN.	HEIGHT			
101	VESTIBULE	CONC.	CT	CT	CONC.	PT	CONC.	PT	CONC.	PT	CONC.	PT	CONC.	PT	CONC.	PT	CONC.	PT	CONC.	PT	ACT	-	9'-0"		
102	LOBBY	CONC.	OP1	VB	CONC.	OP1	VB	CONC.	PT	CONC.	PT	CONC.	PT	CONC.	PT	CONC.	PT	CONC.	PT	CONC.	PT	ACT	-	11'-0"	
103	SANCTUARY	CONC.	OP1	VB	CONC.	OP1	VB	CONC.	PT	CONC.	PT	CONC.	PT	CONC.	PT	CONC.	PT	CONC.	PT	CONC.	PT	ACT	-	11'-0"	
104	PASTOR'S OFFICE	CONC.	OP1	VB	CONC.	OP1	VB	CONC.	PT	CONC.	PT	CONC.	PT	CONC.	PT	CONC.	PT	CONC.	PT	CONC.	PT	ACT	-	9'-0"	
105	HALL	CONC.	CT	CT	CONC.	PT	CONC.	PT	CONC.	PT	CONC.	PT	CONC.	PT	CONC.	PT	CONC.	PT	CONC.	PT	ACT	-	9'-0"		
106	WOMEN'S ROOM	CONC.	CT	CT	CONC.	PT/CT*	CONC.	PT	CONC.	PT/CT*	CONC.	PT	CONC.	PT/CT*	CONC.	PT	CONC.	PT/CT*	CONC.	PT	ACT	-	9'-0"		
107	WOMEN'S ROOM	CONC.	CT	CT	CONC.	PT/CT*	CONC.	PT	CONC.	PT/CT*	CONC.	PT	CONC.	PT/CT*	CONC.	PT	CONC.	PT/CT*	CONC.	PT	ACT	-	9'-0"		
108	HALL	CONC.	OP1	VB	CONC.	OP1	VB	CONC.	PT	CONC.	PT	CONC.	PT	CONC.	PT	CONC.	PT	CONC.	PT	CONC.	PT	ACT	-	9'-0"	
109	UTILITY ROOM	CONC.	VCT	VB	CONC.	PT/FP*	CONC.	PT	CONC.	PT/FP*	CONC.	PT	CONC.	PT	CONC.	PT	CONC.	PT	CONC.	PT	ACT	-	9'-0"		
110	SAUNTERS CLOSET	CONC.	VCT	VB	CONC.	PT/FP*	CONC.	PT	CONC.	PT/FP*	CONC.	PT	CONC.	PT	CONC.	PT	CONC.	PT	CONC.	PT	ACT	-	9'-0"		


FINISH SCHEDULE LEGEND:
ACT ACQUISITIONAL CEILING TILE SYSTEM
CONC CONCRETE
OP1 CEMENT TILE
CT CERAMIC TILE
FP FIBERGLASS-REINFORCED PANEL
CONC GYPSUM WALLBOARD
PT PAINT
VB VINYL BASE
VCT VINYL COMPOSITE TILE

* CONTRACTOR SHALL COORDINATE ALL FINISH SELECTIONS WITH OWNER PRIOR TO INSTALLATION.

1 REFLECTED CEILING PLAN
SCALE: 1/4" = 1'-0"

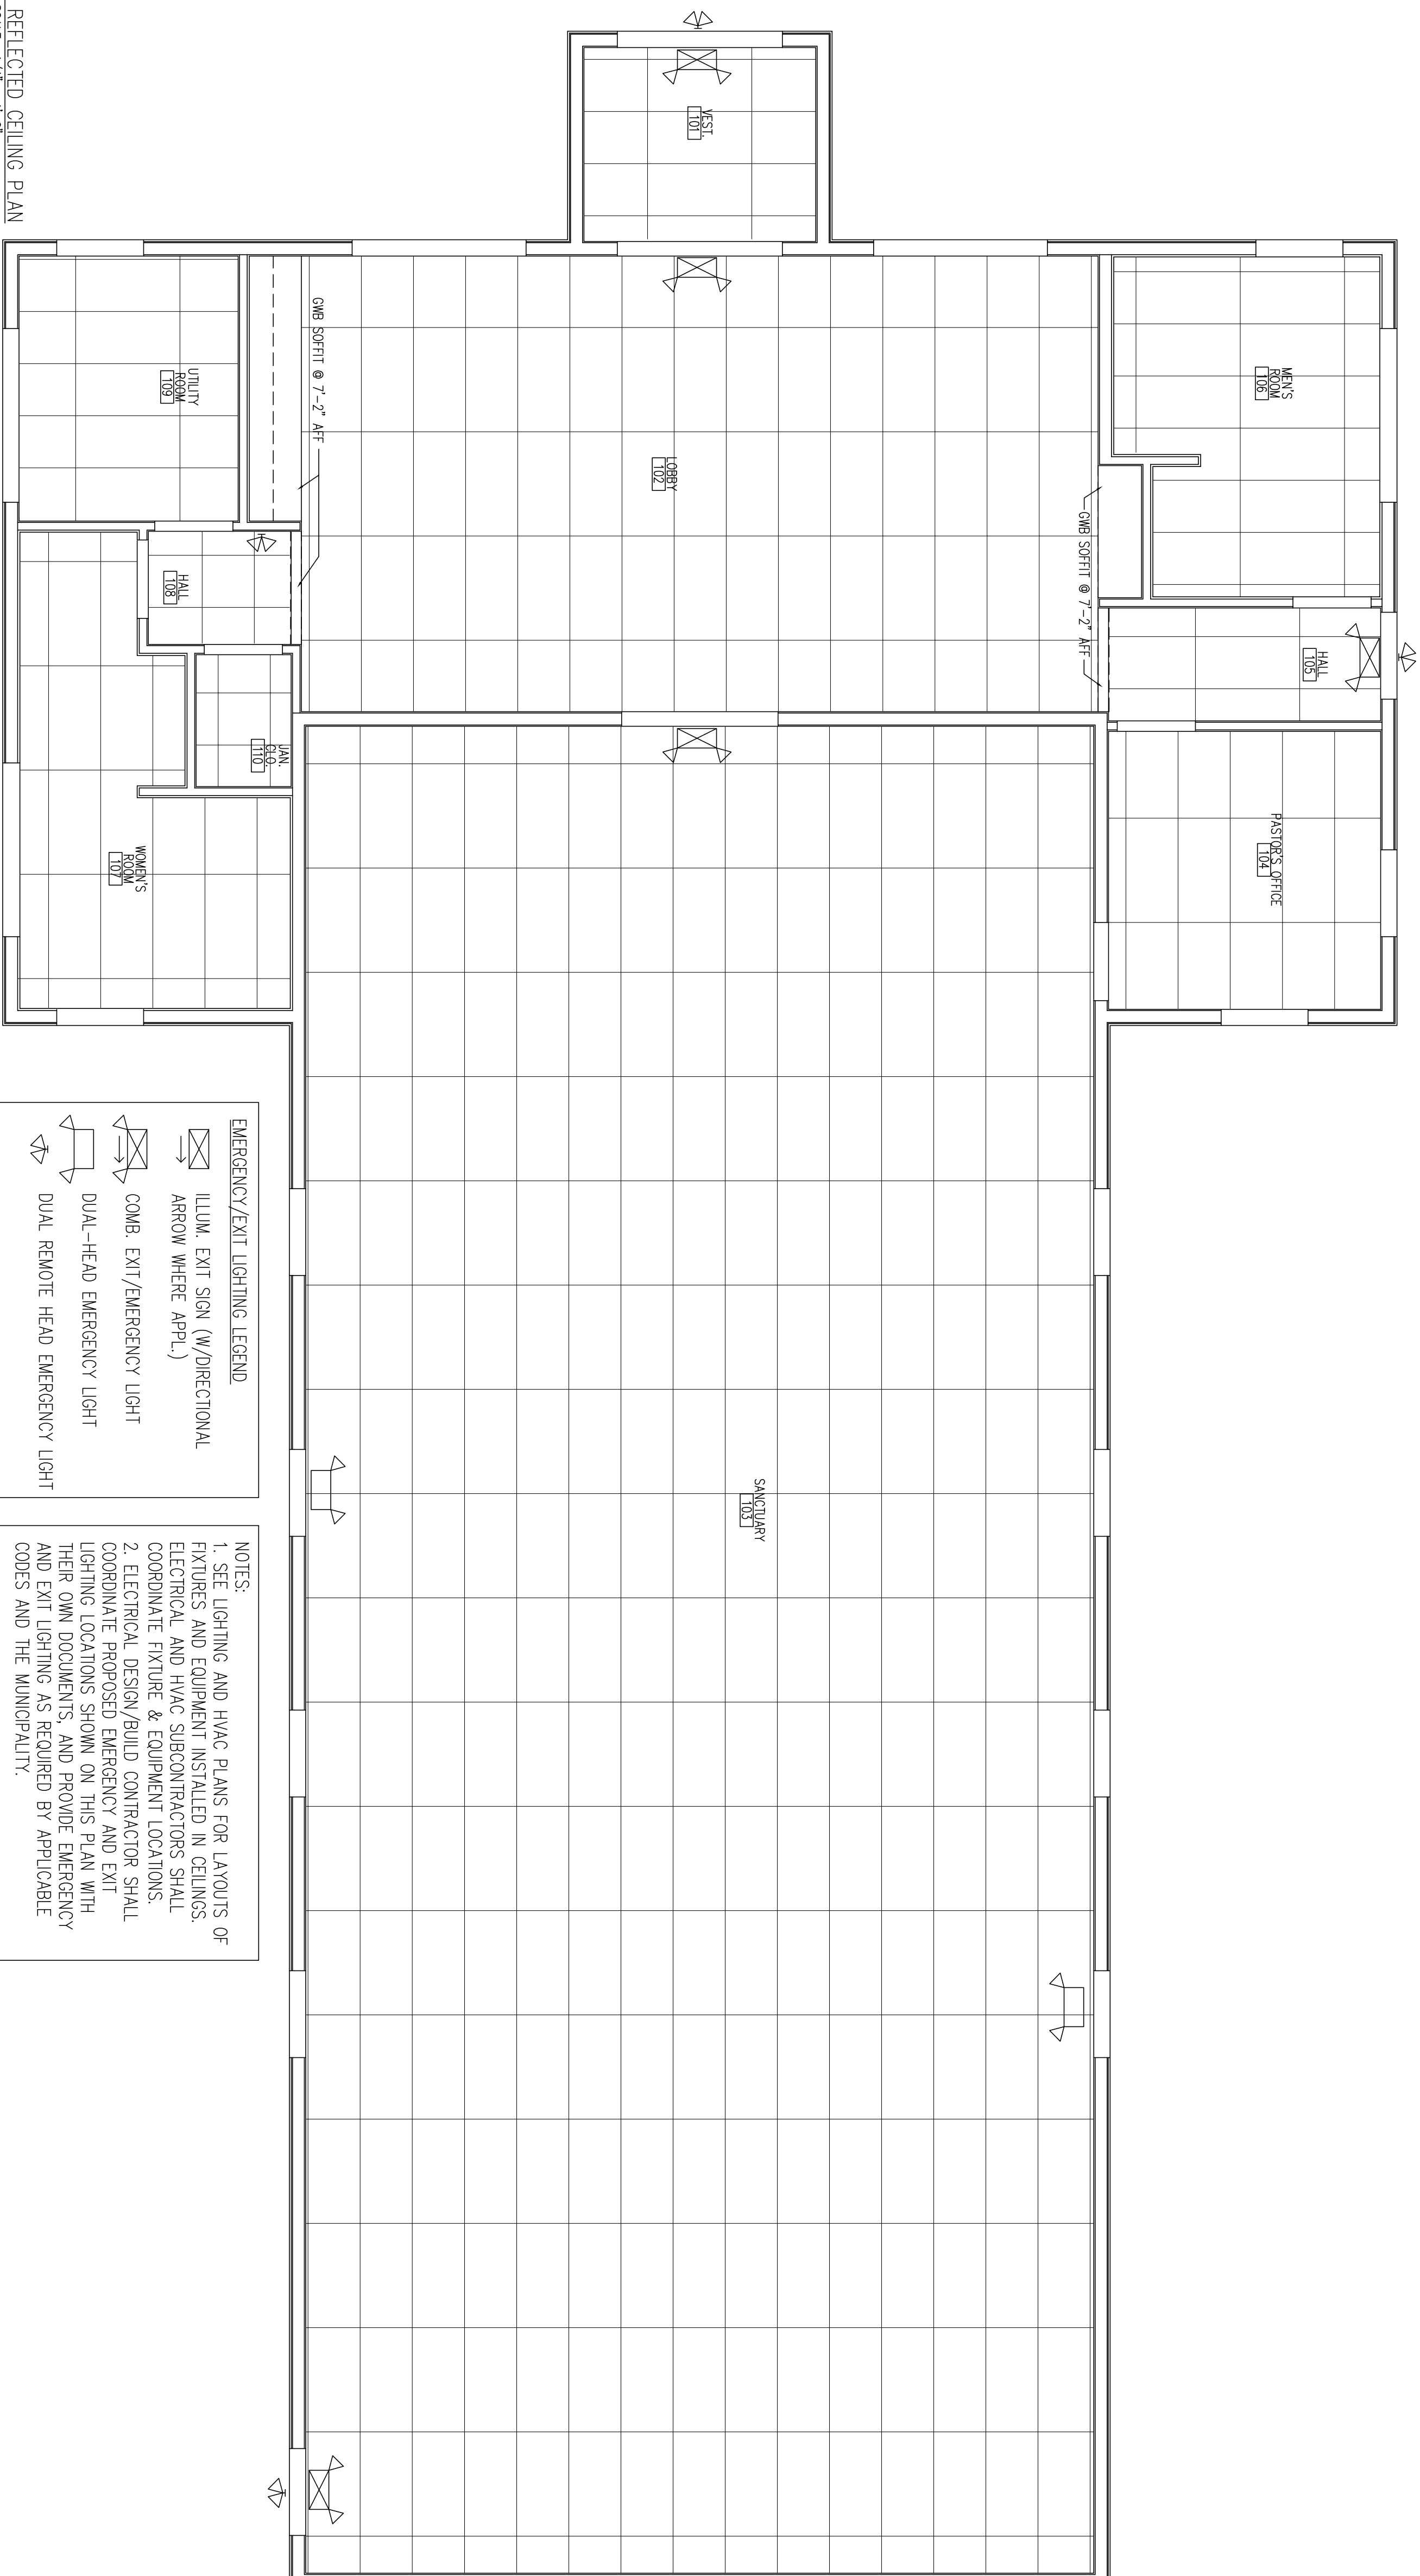

NOTES:
1. SEE LIGHTING AND HVAC PLANS FOR LAYOUTS OF FIXTURES AND EQUIPMENT INSTALLED IN CEILINGS. ELECTRICAL AND HVAC SUBCONTRACTORS SHALL COORDINATE FIXTURE & EQUIPMENT LOCATIONS.
2. ELECTRICAL DESIGN/BUILD CONTRACTOR SHALL COORDINATE PROPOSED EMERGENCY AND EXIT LIGHTING LOCATIONS SHOWN ON THIS PLAN WITH THEIR OWN DOCUMENTS, AND PROVIDE EMERGENCY AND EXIT LIGHTS AS SHOWN AND PROVIDED BY APPLICABLE CODES AND THE MUNICIPALITY.

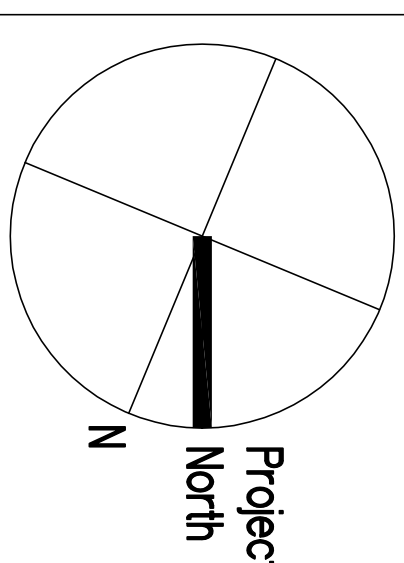

ATTHOUSE, JAFFE & ASSOCIATES, LLC
ARCHITECTS AND INTERIORS
758 BERKOWENVILLE ROAD
PENNSYLVANIA, PA 19074
TEL: 610.754.9390 610.754.9392 FAX

In His Presence Church
Block 6701, Lot 3
Franklin Township, NJ
Proposed New Church Building

Date: 3/2/2015

Revision: _____
Checked: _____
Drawn By: _____
File No: 11123a
Scale: As Noted
Reflected Ceiling Plan & Finishes
A701

This document is the property of Atthouse, Jaffe & Associates, LLC. It is not to be used, copied, or reproduced in any form without the written consent of the Architect.